


CONSTRUCTION TYPES LEGEND


- FLOORS**
FLOOR NOTES: FLOOR FINISHES ARE INDICATED ON THE FINISH SCHEDULE. REFER TO "AM" SERIES SHEETS FOR BELOW GRADE WATERPROOFING AND SUBROOF LOCATIONS. ALL SUBROOF SYSTEMS TO RECEIVE R-20 BATT INSULATION w/ STICK PINS AT UNDERSIDE.
- CONCRETE SLAB FINISH NOTES:**
 UNPROTECTED CONCOURSES: BROOM PROTECTED CONCOURSES: LIGHT BROOM PRECAST SEATING RISERS: BROOM OVER BUILT BOWL SLABS: BROOM INTERIOR EXPOSED STEEL TROWEL INTERIOR TO RECEIVE FINISH. TBD PER FINISH REQUIREMENT
- F1 CONCRETE SLAB-ON-GRADE * SAND BED
 * VAPOR BARRIER
 FILL STRUCTURAL OR DRAINAGE)
 F2 ELEVATED STRUCT. CONCRETE SLAB
 F3 MMA FLOOR TOPPING
 STRUCTURAL CONCRETE SLAB
 R-30 BATT INSULATION w/ STICK PINS
 F4 STRUCTURAL PRECAST TREAD UNITS
 F5 4" CONCRETE TOPPING SLAB
 2" RIGID EPS INSULATION BOARD
 DRAINAGE BOARD
 WATERPROOF MEMBRANE
 ELEVATED STRUCT. CONCRETE SLAB
- ROOFS**
 R1 BIRDAIR "ENOTHERM" FABRIC ROOF SYSTEM - RE: ROOF STRUCTURE DWGS.
 R2 2-1/2" "VERSAPANEL" ROOF PANELS (R-15 COMPOSITE INSULATED) PAINTED COLD FORMED PURLIN FRAMING
 R3 THERMOPLASTIC MEMBRANE ROOFING (CUSTOM - CONCEALED FASTENERS) PVC AIR BARRIER
 R-15 RIGID INSULATION BOARDS
 STRUCT. METAL ROOF DECK
- SOFFITS & FASCIAS**
 S1 PORTLAND CEMENT PLASTER (3 COAT) LATHING SOFFIT SUSPENSION SYSTEM
 R-19 BATT INSULATION
 S2 METAL SOFFIT PANELS (LAPPED - CONCEALED FASTENERS) W.P. UNDERLAYMENT GYPSUM SHEATHING BOARD LIGHT GAGE METAL FRAMING
 R-19 BATT INSULATION
 S3 METAL FASCIA PANELS (CUSTOM - CONCEALED FASTENERS) W.P. UNDERLAYMENT GYPSUM SHEATHING BOARD LIGHT GAGE METAL FRAMING
 R-19 BATT INSULATION

- WALLS**
 WALL NOTES: INTERIOR WALL FINISHES ARE INDICATED ON THE FINISH SCHEDULE. SUBSTITUTE TILE BACKER BOARD FOR GYPSUM WALL BOARD WHERE REQUIRED FOR FINISHES.
- W1 2-1/2" "FORMAWALL" WALL PANELS (R-19 COMPOSITE INSULATED) PAINTED COLD FORMED PURLIN FRAMING (SEE WALL ALTERNATES SCHEDULE)
 W2 2-1/2" "FORMAWALL" WALL PANELS (R-19 COMPOSITE INSULATED) PAINTED LIGHT GAGE PURLIN FRAMING COLD FORMED METAL FRAMING
 5/8" GYPSUM WALLBOARD (SEE WALL ALTERNATES SCHEDULE)
 W3 PORCELAIN TILE (SEE ELEVS.) PORTLAND CEMENT MORTAR BED TILE BACKER BOARD
 W.P. MEMBRANE
 COLD FORMED METAL FRAMING
 R-19 BATT INSULATION
 5/8" GYPSUM WALLBOARD
 W4 PORTLAND CEMENT PLASTER (3 COAT) LATHING
 W.P. MEMBRANE
 GYPSUM SHEATHING BOARD
 COLD FORMED METAL FRAMING
 R-19 BATT INSULATION
 5/8" GYPSUM WALLBOARD
 W5 TTE TRANSLUCENT WALL PANELS
 W6 STRUCTURED POLYCARBONATE PANELS


- GLAZING SYSTEMS**
 G1 CURTAINWALL SYSTEM (RE: ELEVS.) (RE: SECTIONS 084413 & 08B700)
 G2 METAL-FRAMED SKYLIGHTS (RE: ELEVS.) (RE: SECTION 086300)
 G3 HORIZONTAL SLIDING WALL SYSTEMS (STACKABLE - RE: ELEVS.) (RE: SECTION 085115)
 G4 HORIZONTAL SLIDING WALL SYSTEMS (NON STACKABLE - RE: ELEVS.) (RE: SECTION 085115)
 G5 FIXED BUTT GLAZED WINDOW SYSTEMS (RE: SECTION 084413)
 G6 TICKET WINDOW UNITS (RE: SECTION 085699)
 G7 CUSTOM TICKET WINDOW ASSEMBLIES (S.S. DEAL TRAY & B.R. GLAZING INFILL WITH CURTAINWALL)
 G8 OVERHEAD STACKING GLAZED WALL (REFERENCE "MV" SERIES DRAWINGS FOR ADDITIONAL INFORMATION)

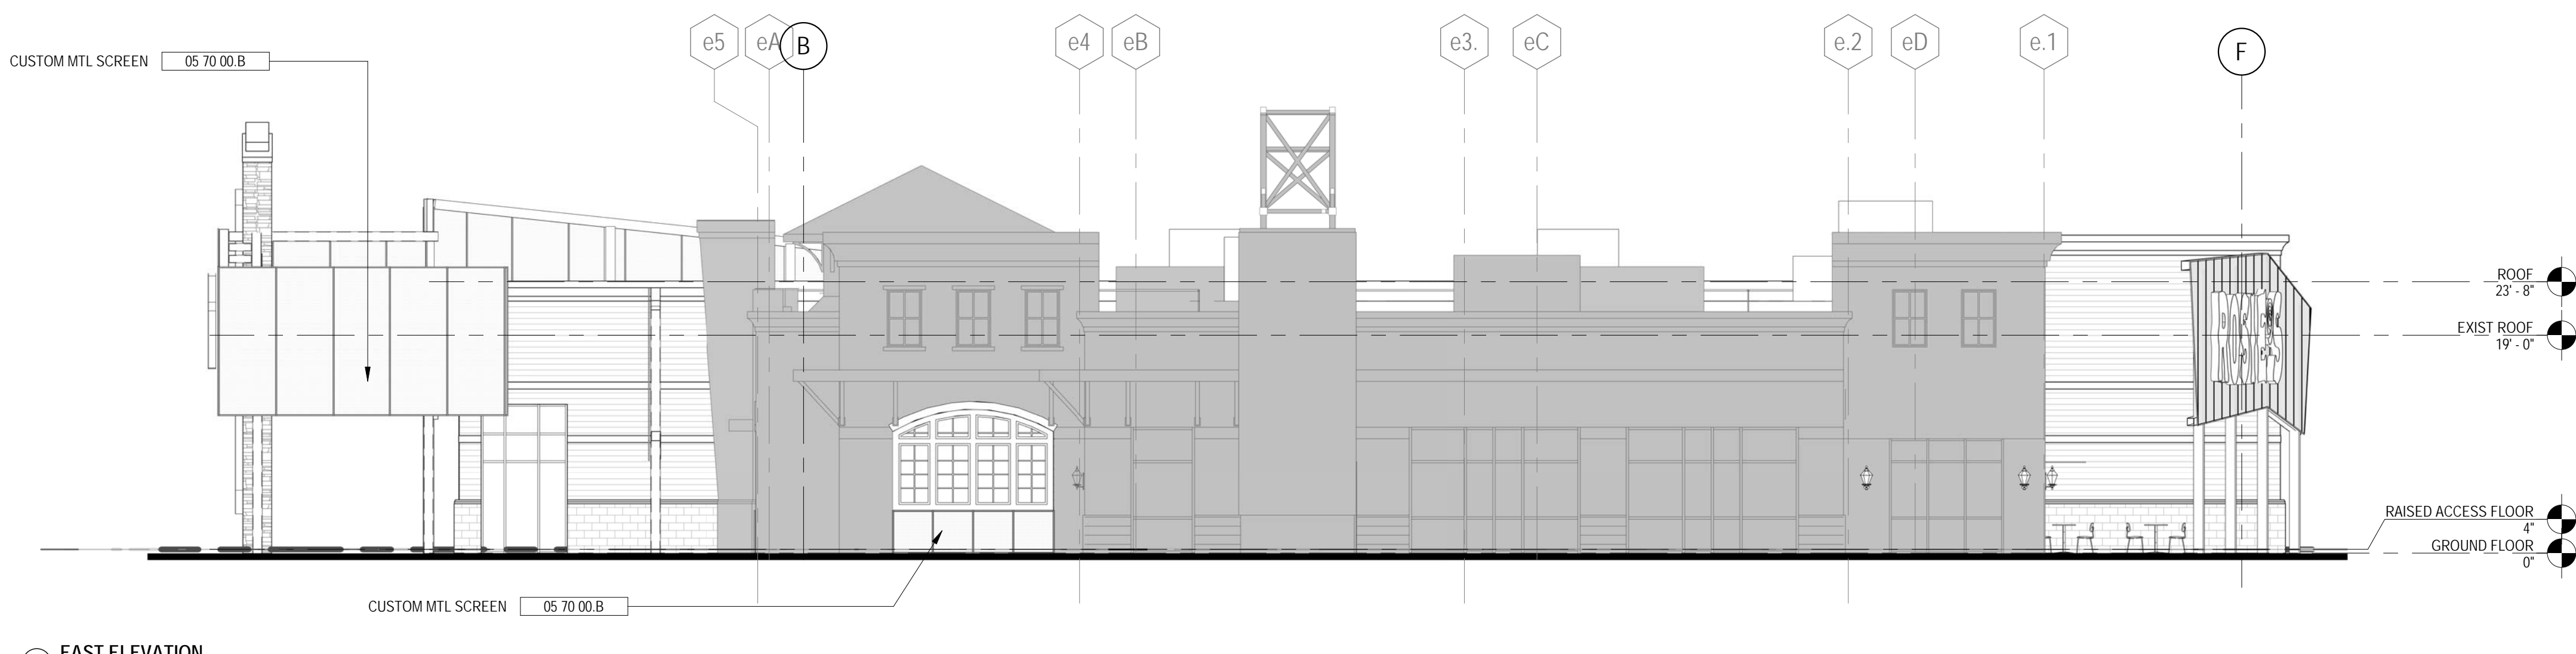


4 EAST ELEVATION
1" = 10'-0"

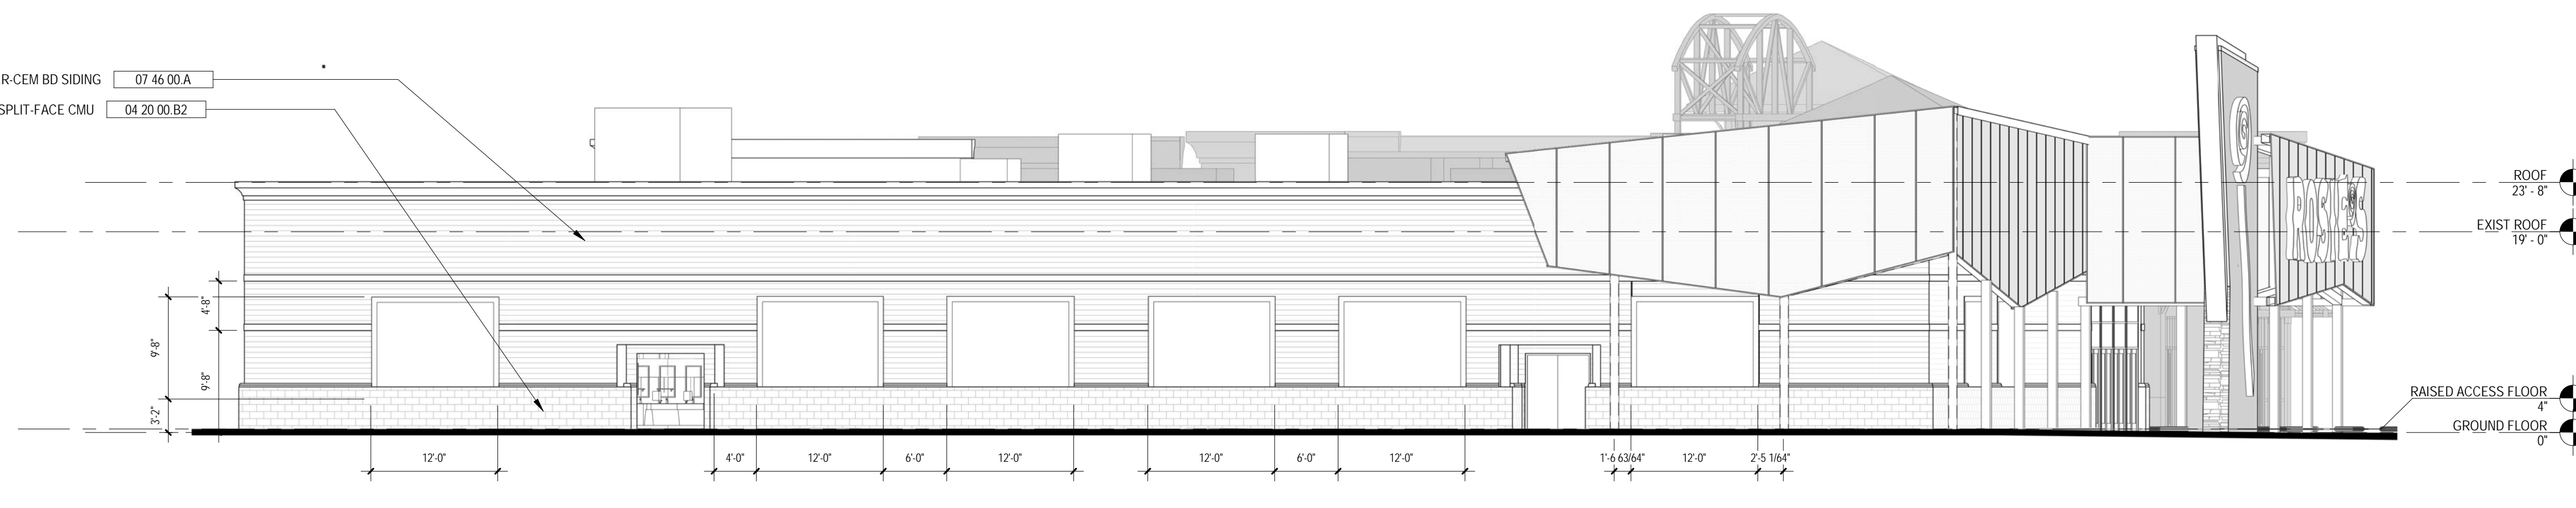

3 WEST ELEVATION
1" = 10'-0"

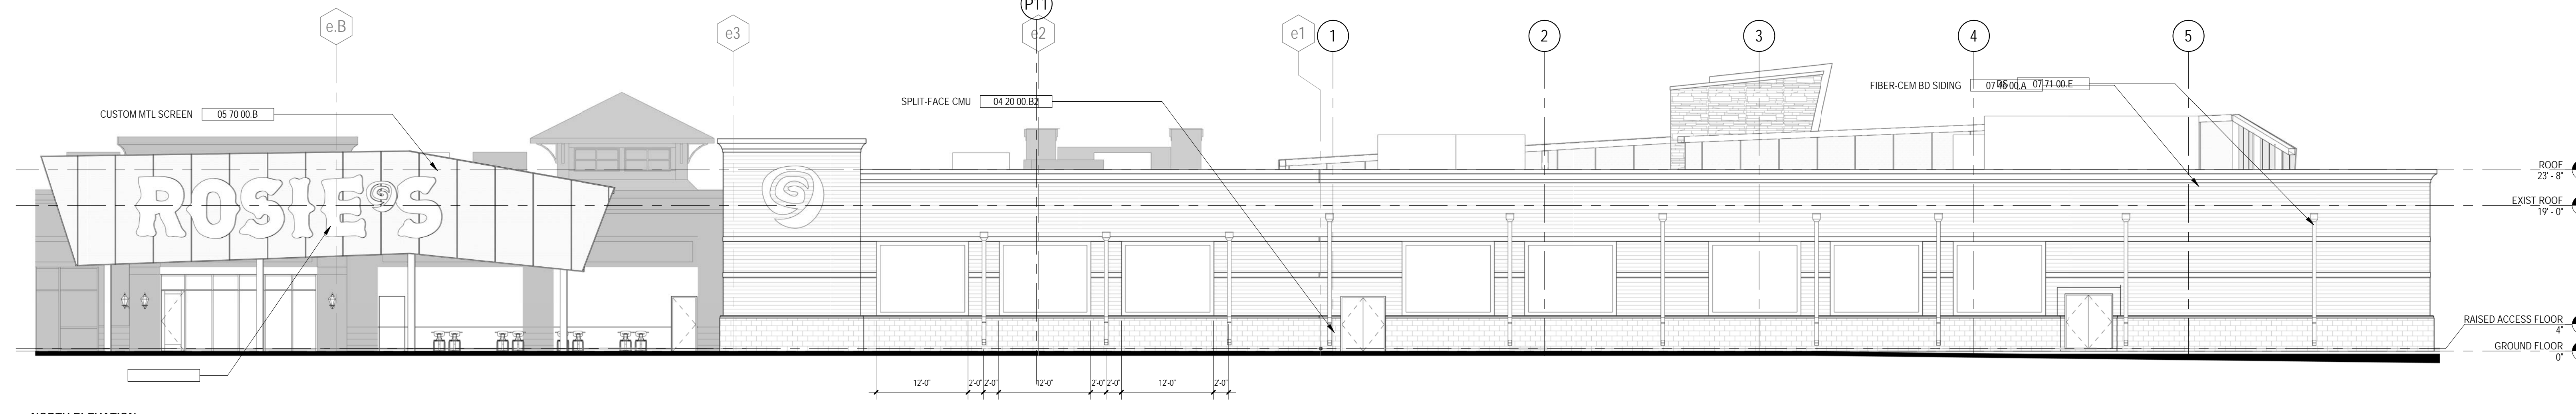

2 NORTH ELEVATION
1" = 10'-0"

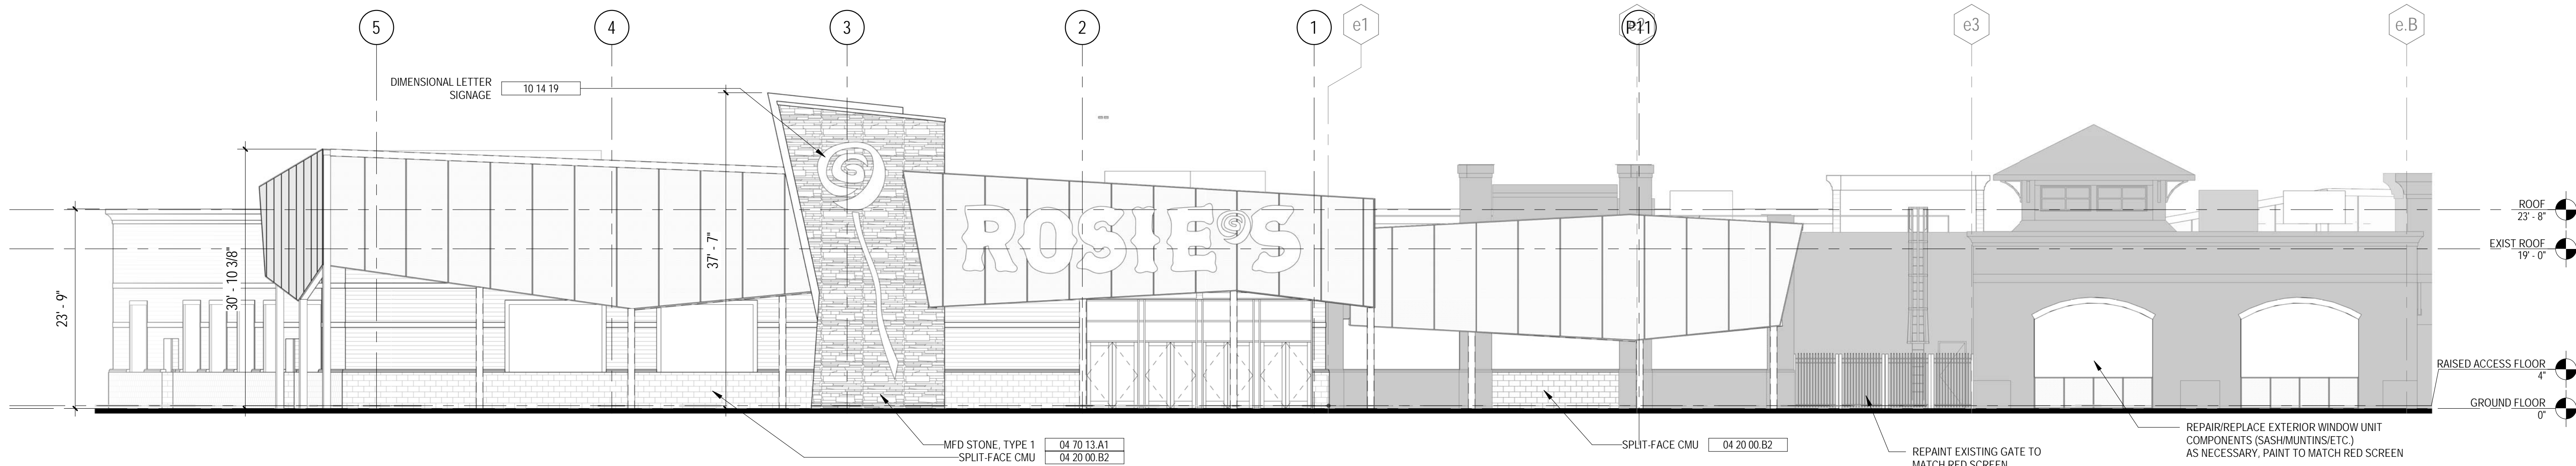

1 SOUTH ELEVATION
1" = 10'-0"


FOR REFERENCE ONLY - NOT FOR CONSTRUCTION

HAMPTON OTB
1996 Power Plant Parkway
Hampton, VA 23666

OCTOBER 18, 2018

REVISIONS

NO.	DATE	DESCRIPTION

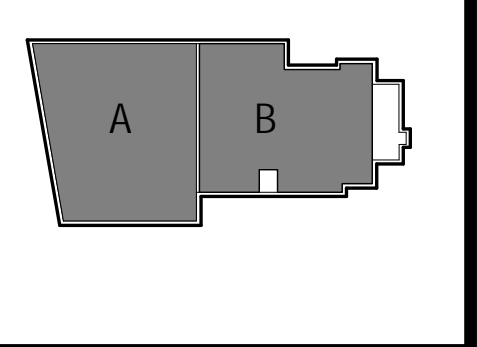

PROJECT 18.4696 ISSUED BY POPULOUS

ISSUED 10/20/18

BUILDING REFERENCE ELEVATIONS

DISCIPLINE CATEGORY SUB-CATEGORY